




REPRODUCTION OF THIS DOCUMENT AND THE INFORMATION CONTAINED HEREIN MAY NOT BE REPRODUCED OR EXCEPTED FROM WITHOUT THE EXPRESS WRITTEN PERMISSION OF PROCHASKA & ASSOCIATES. UNAUTHORIZED COPYING, DISCLOSURE OR CONSTRUCTION USE ARE PROHIBITED BY COPYRIGHT LAW. © COPYRIGHT 2017 PROCHASKA & ASSOCIATES, INC.



OPTION

4

SCHEMATIC 2ND FLOOR PLAN  
SCALE: 1/16" = 1'-0"

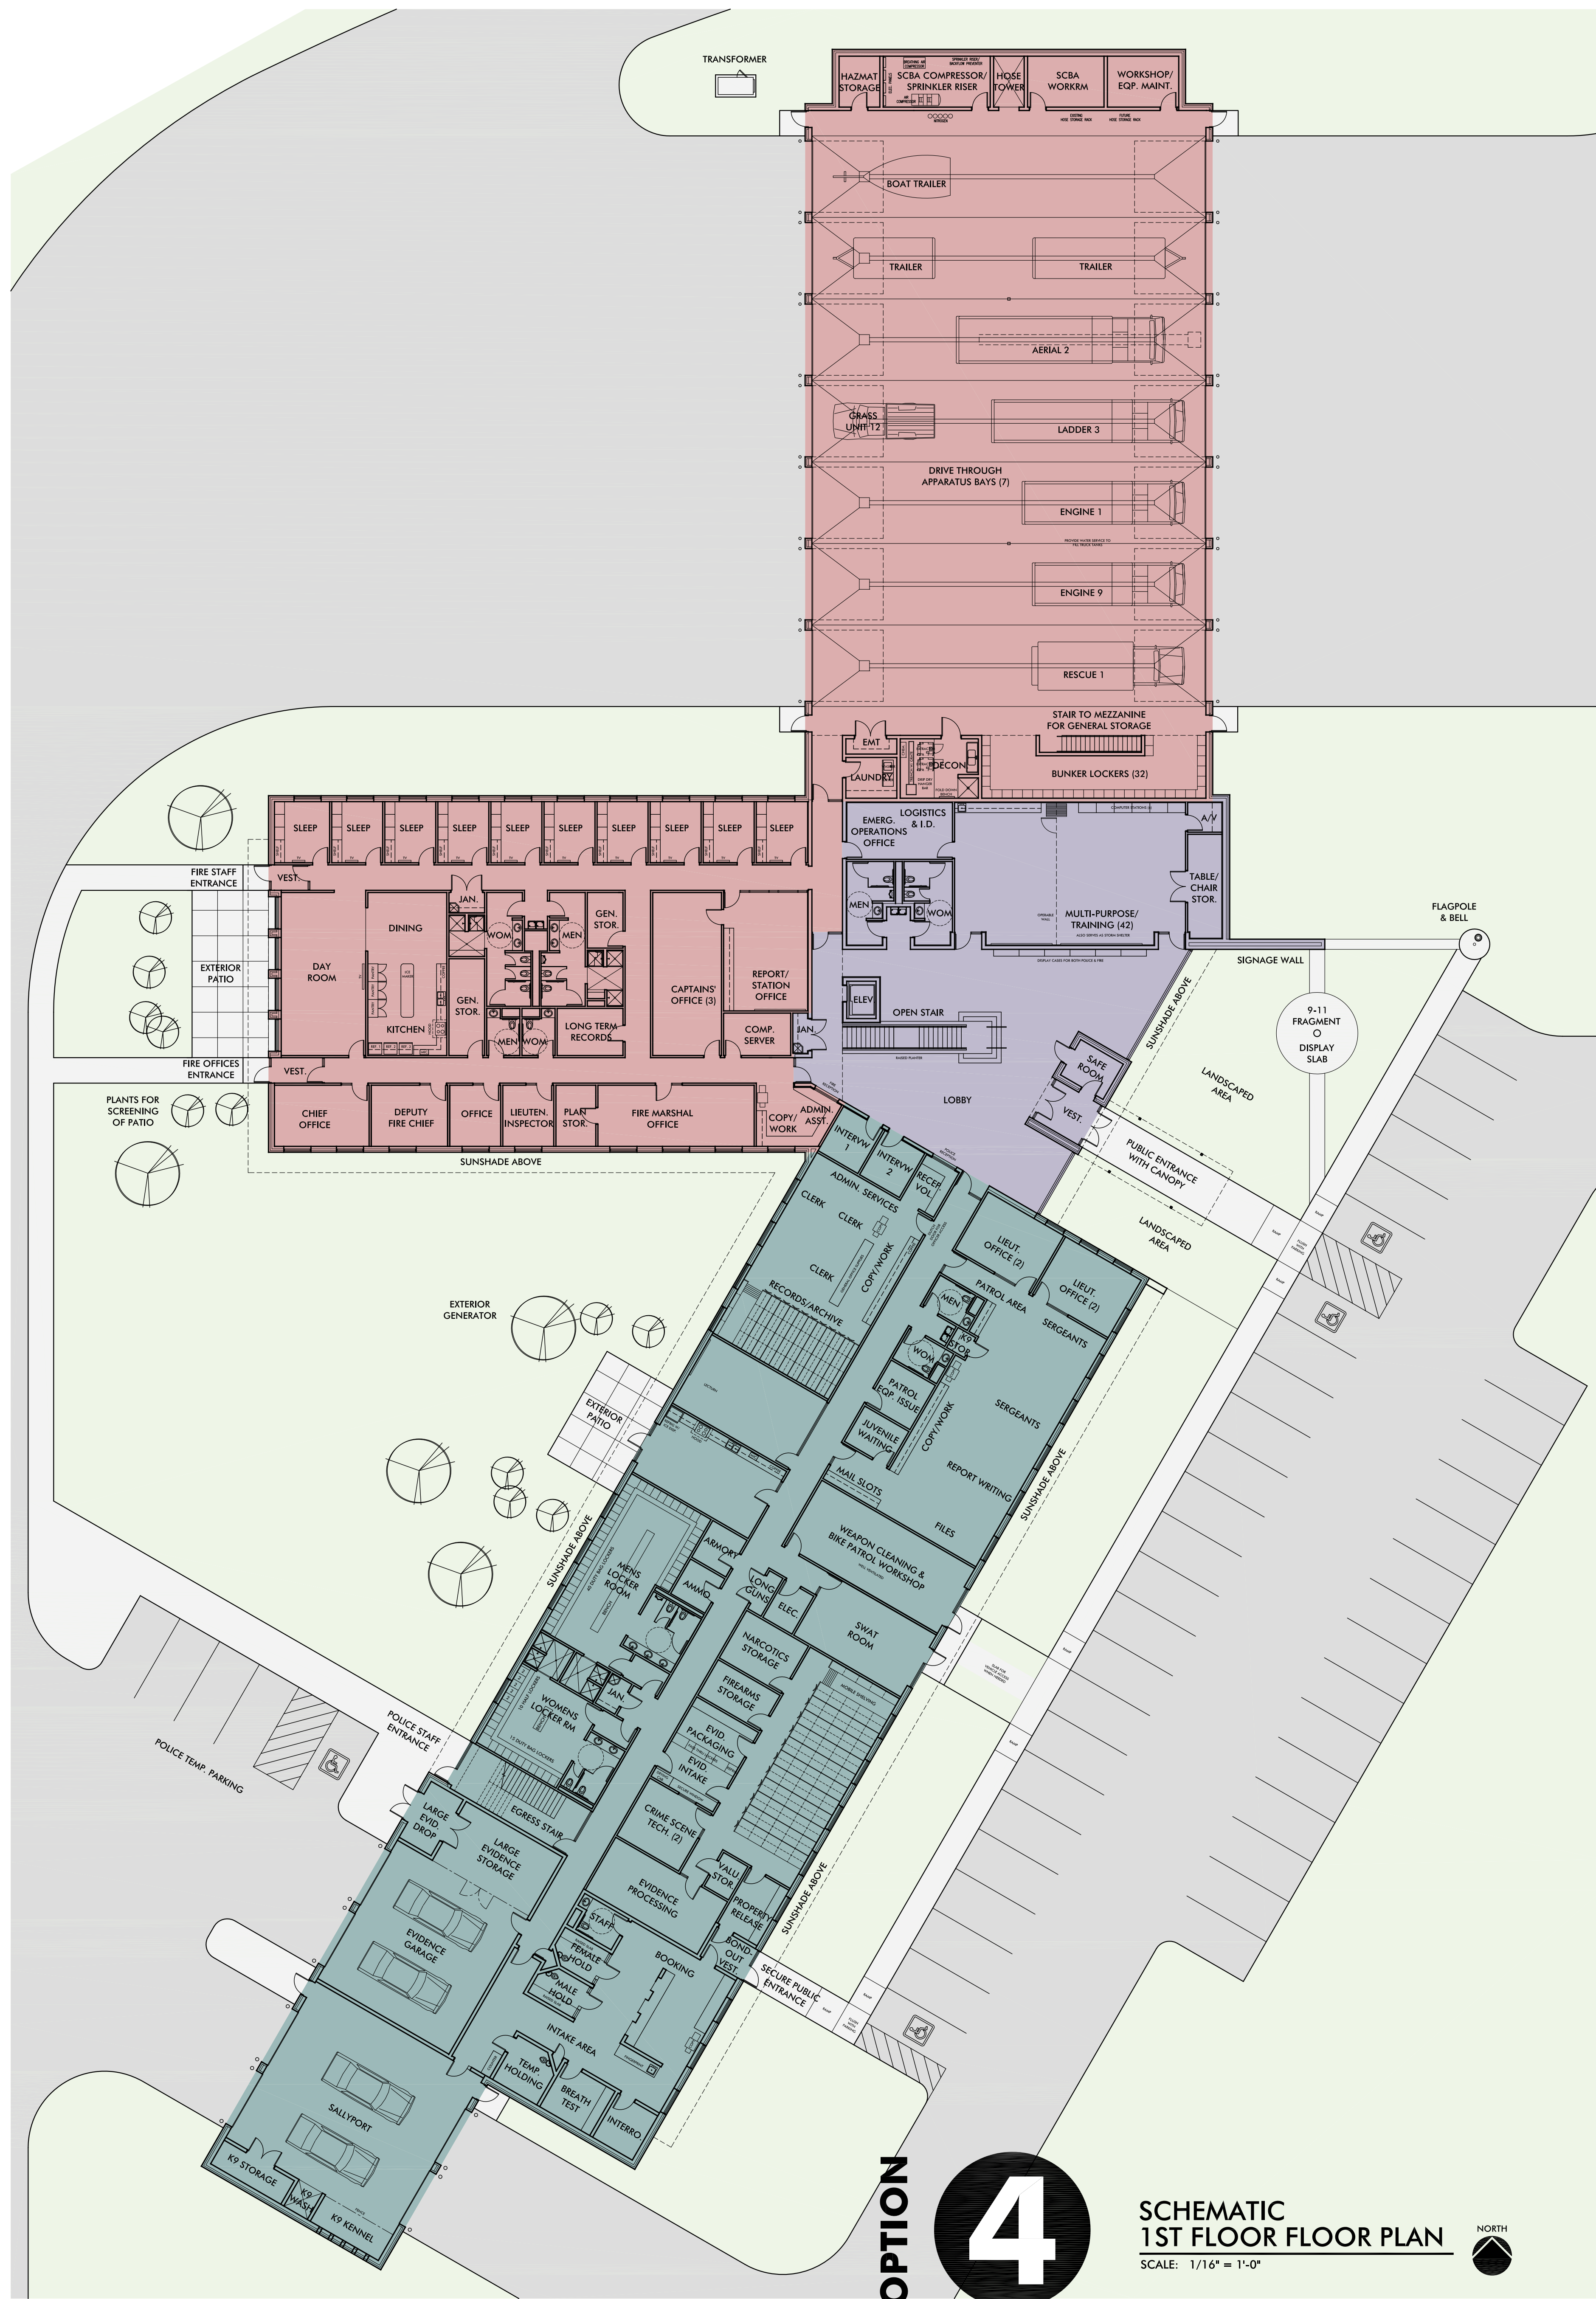

OPTION

4

SCHEMATIC 1ST FLOOR PLAN  
SCALE: 1/16" = 1'-0"



# JOINT POLICE & FIRE STATION

MARSHALLTOWN, IOWA 50158